


SPECIAL UNIT PRINT
 I HEREBY CERTIFY THAT I HAVE
 THOROUGHLY REVIEWED THIS CONSTRUCTION
 PRINT AND CONFIRM THAT IT IS CORRECT

DEALER : _____
 CUSTOMER : _____
 DATE : _____

SPECIAL UNIT FOR
 DEALER: KREATIVE HOMES
 CUSTOMER: ALMARAZ
 ACTUAL DIMENSIONS OF HOME
 29'-0" x 72'-0"

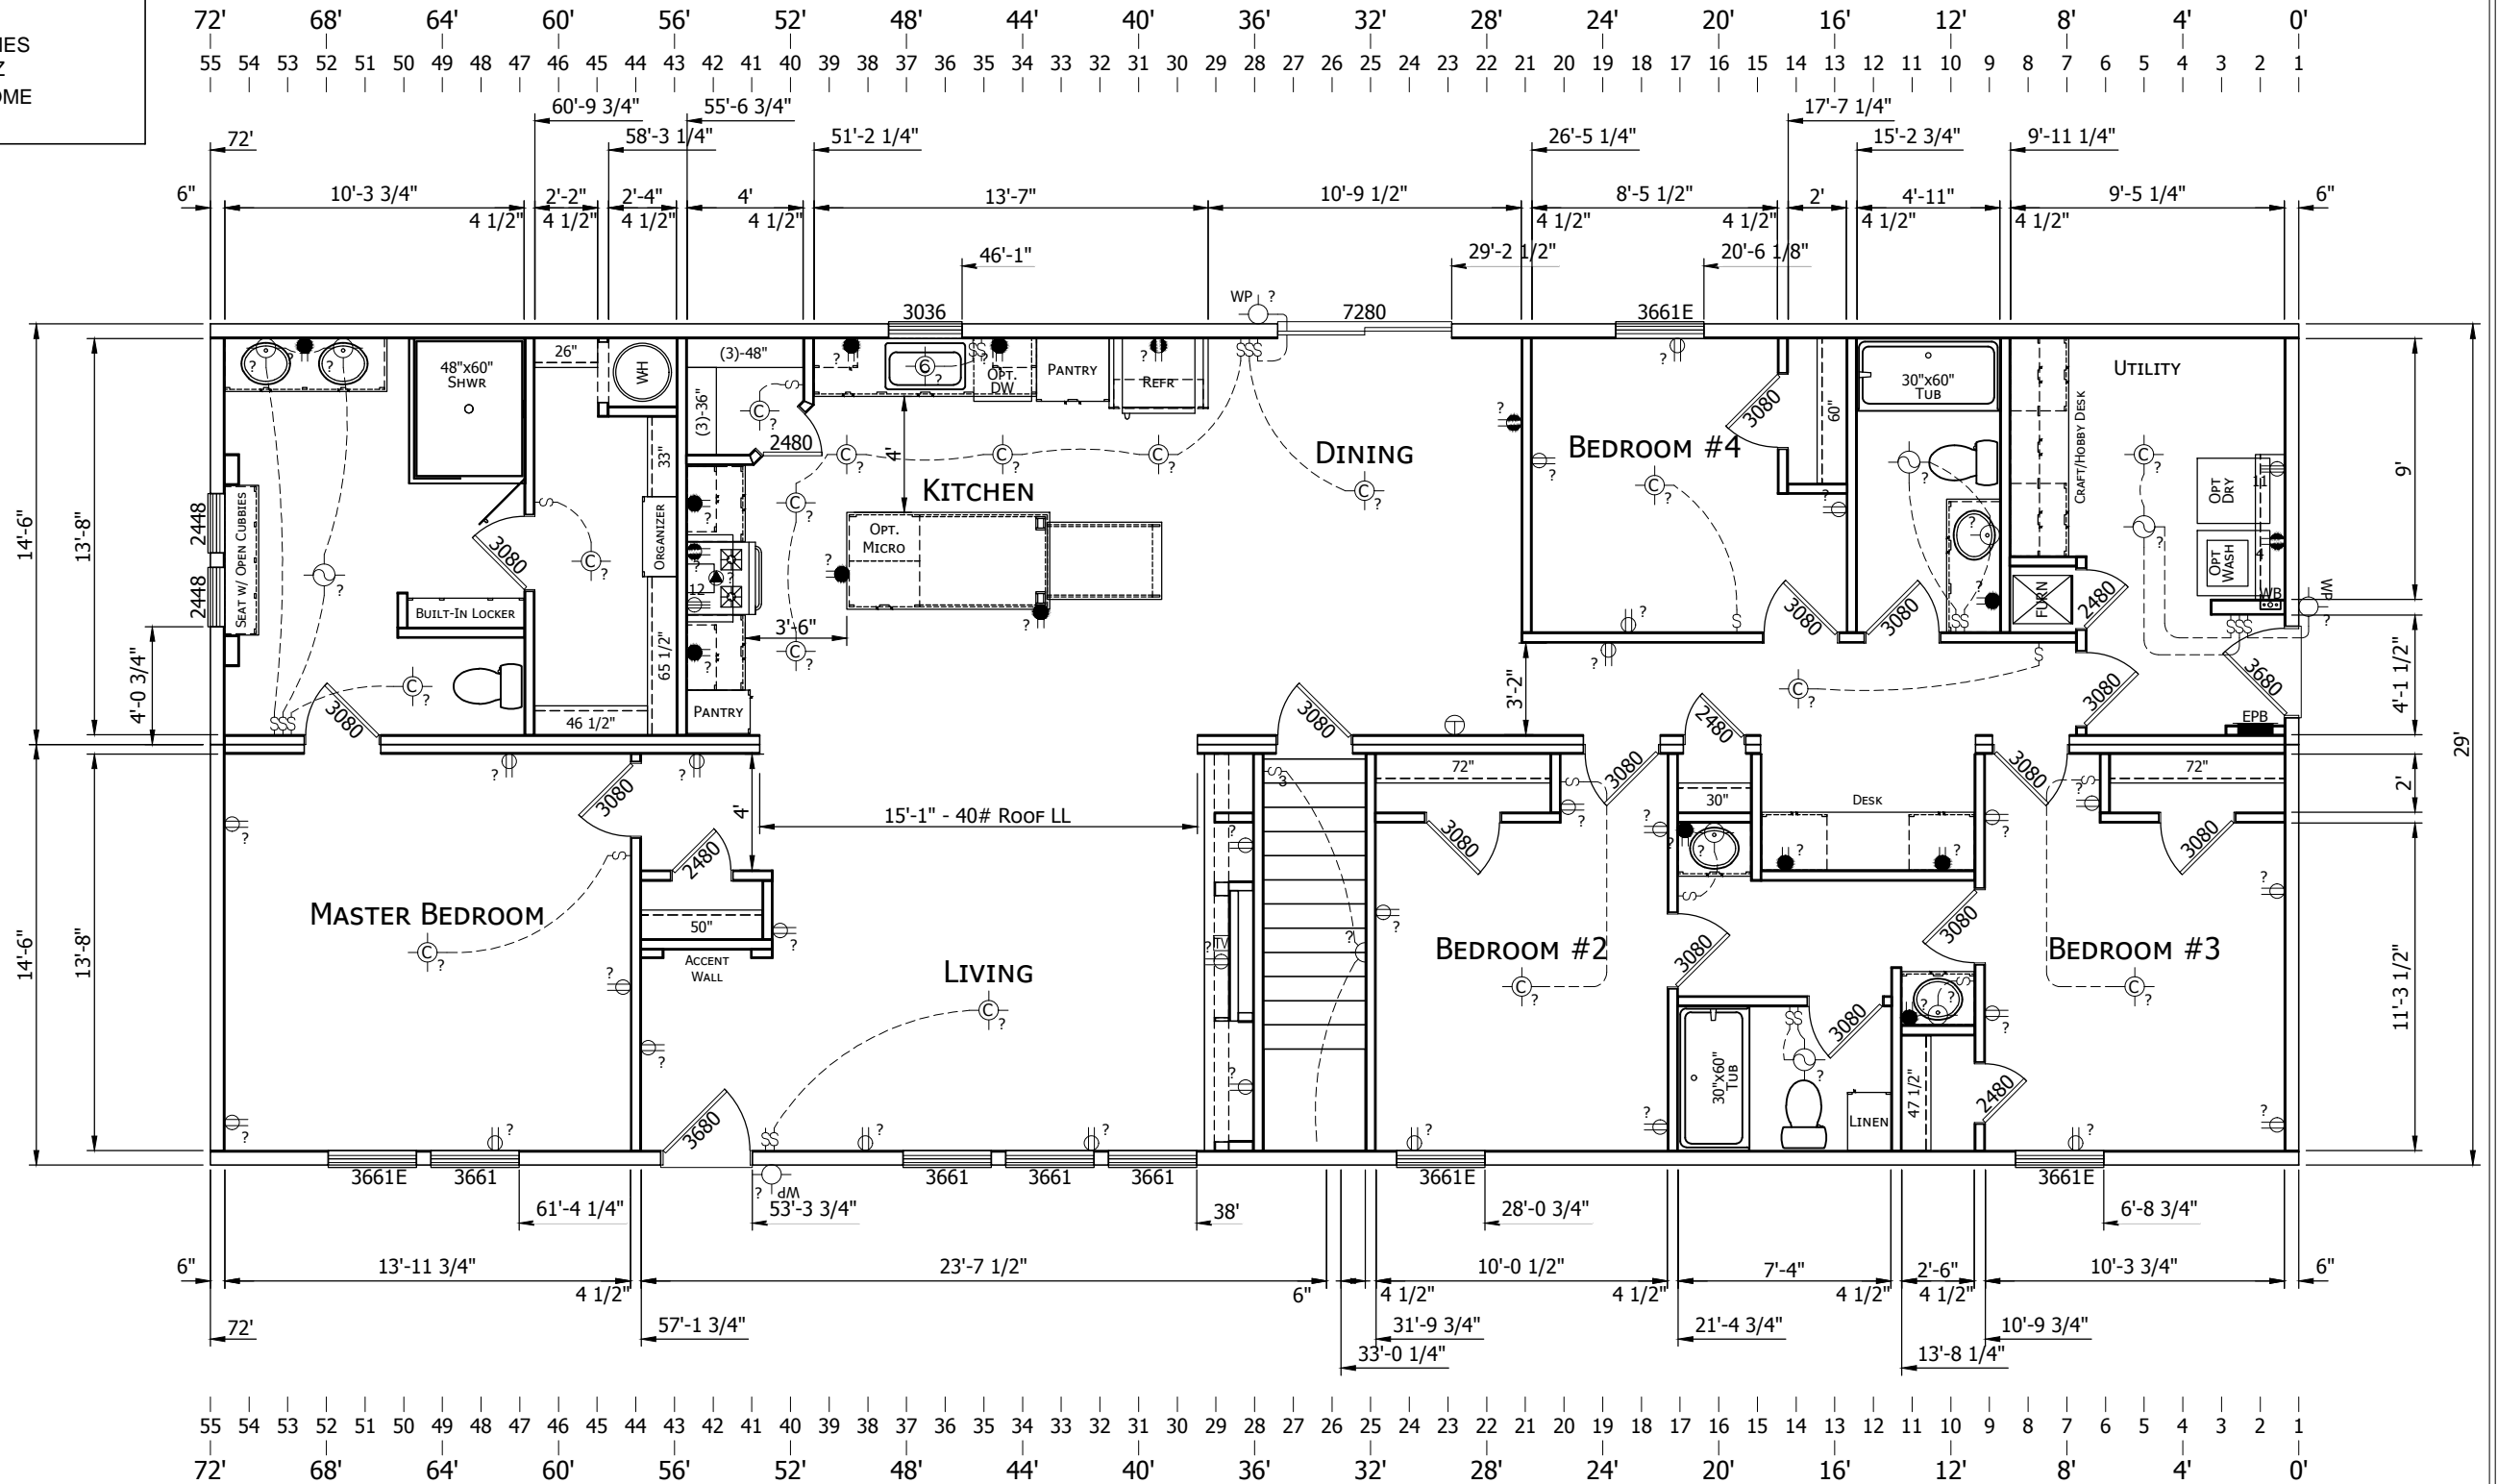

CHAMPION

MANUFACTURED BEAUTIFULLY™

3200 ENTERPRISE AVE. YORK, NE 68467

MODIFICATIONS

PROJECT:
CATENA - 72B VERSION
 29' x 72' 4 BD 3 BTH

DRAWN BY:
 DATE:
 SCALE: 5/32" = 1'-0"

TITLE:
FLOOR PLAN
ELECTRICAL PLAN

FILENAME: 05-CTN 72B MOD-KREATIVE HOMES-ALMARAZ

SHEET:
AP-101

PROPRIETARY AND CONFIDENTIAL
 THESE DRAWINGS AND SPECIFICATIONS ARE ORIGINAL
 PROPRIETARY AND CONFIDENTIAL MATERIALS OF CHAMPION.
 COPYRIGHT © 1976-2021 BY CHAMPION